
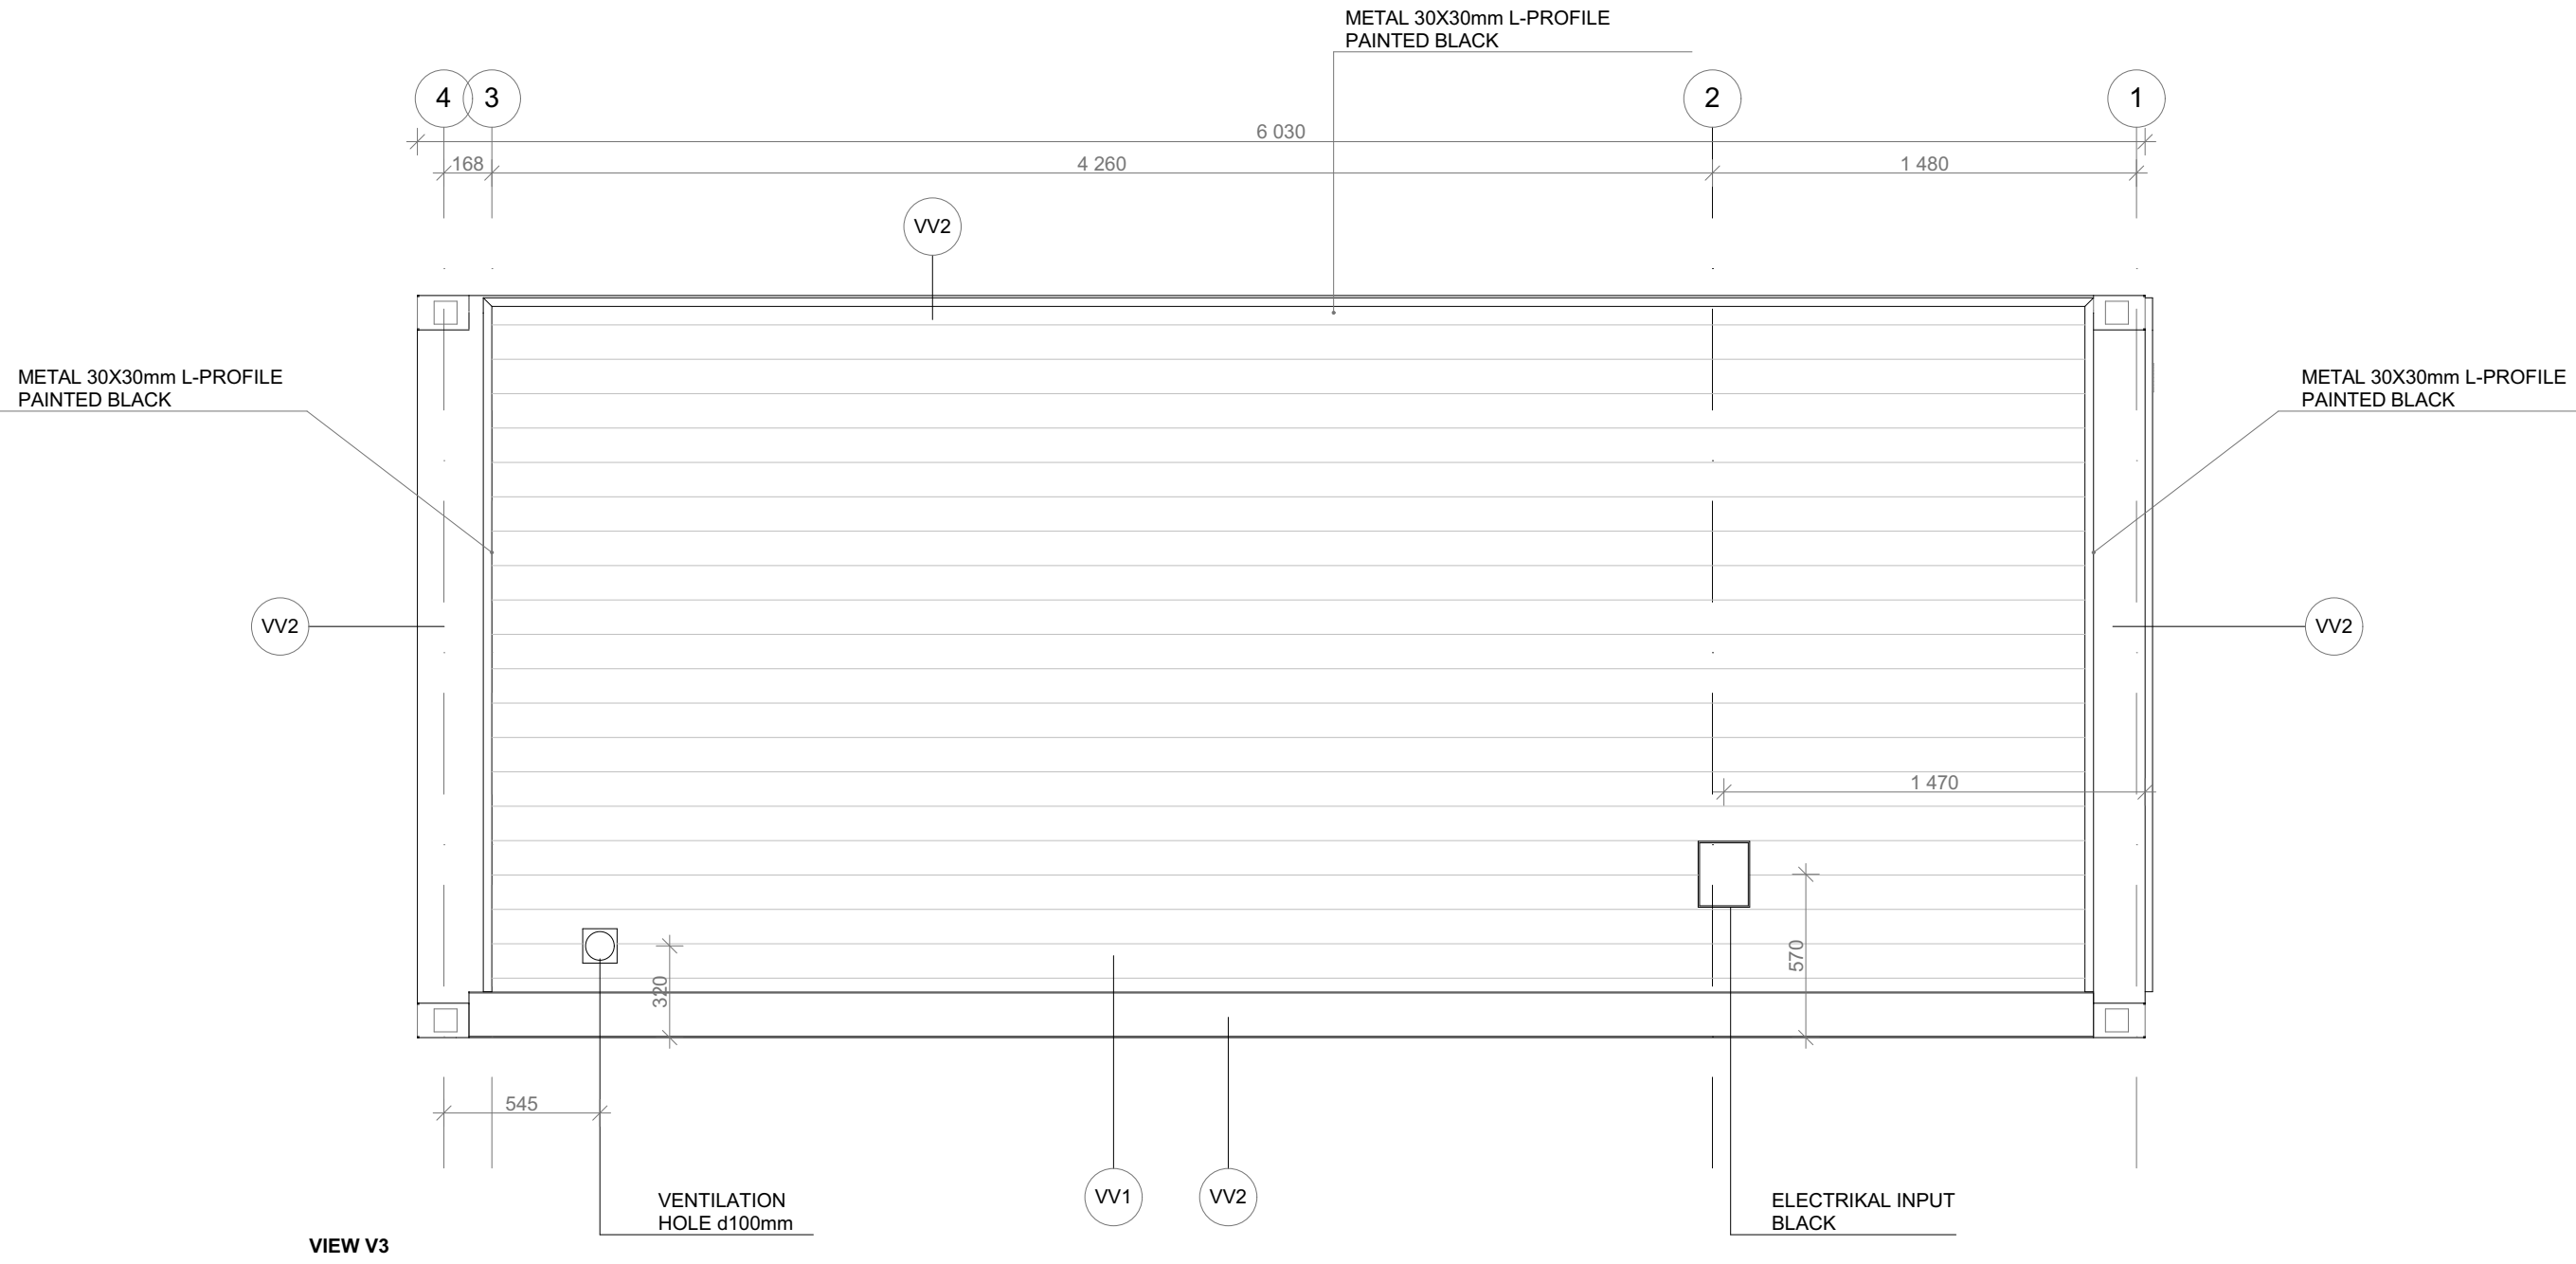
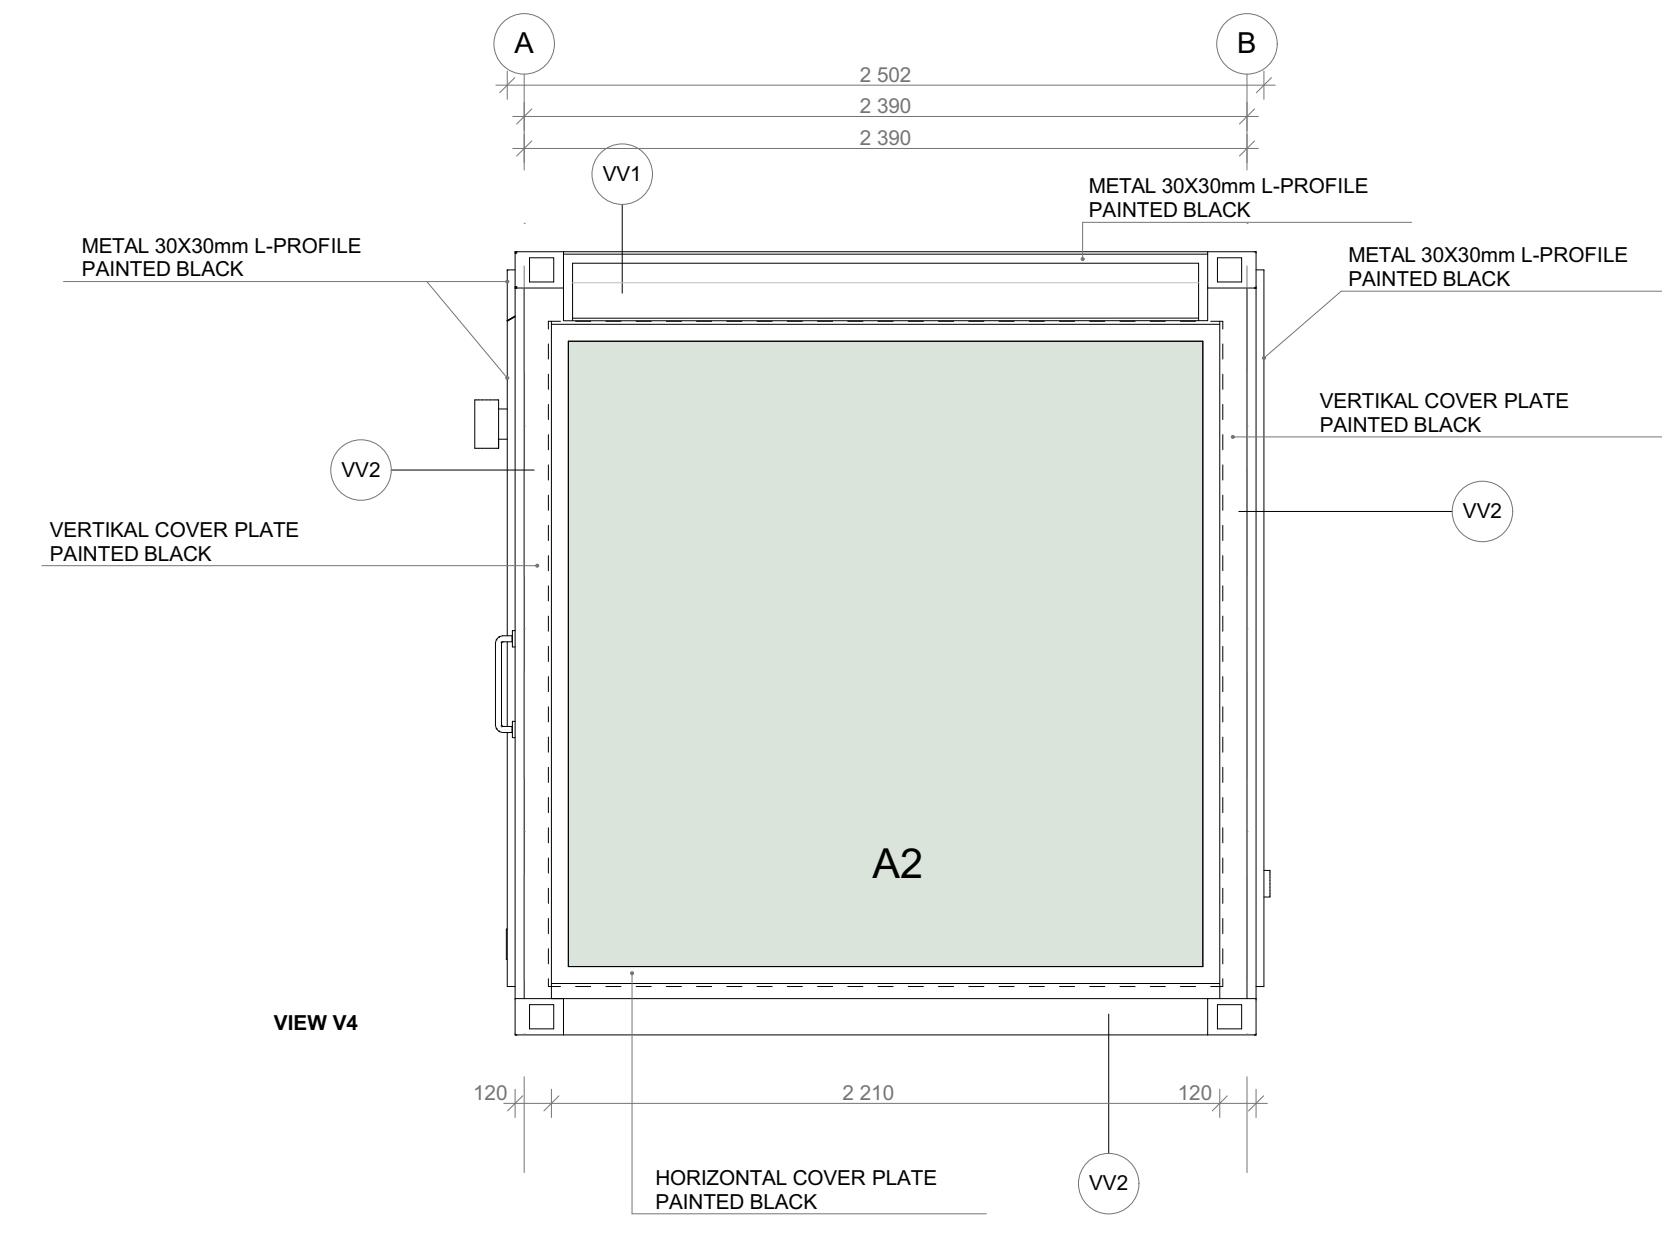


SYMBOLS
EXTERIOR FINISHING

- VW1 HORIZONTAL WALL BOARD 120...145X18mm, LARCH, PINE, SPRUCE WOOD
SEE FINISHING MATERIALS SPECIFICATION
- VW2 METAL FRAME PAINTED BLACK

WINDOWS AND DOORS SEE OPEN FILLING SPECIFICATION

SUBSCRIBER		ARRO PROJEKT OÜ EP 11013477 - 0001					
OBJECT ADDRESS	CONTAINER TYPE 2 (RIGHT)		ARCHITECT / Vol. VII		PROJECTOR		ANNES ARRO
DRAWING	PLAN AND VIEW V1 AND VIEW V2	PART AR	PHASE PP	WORK NR	TIME	DOC.MARKING	SCALE
				18.10.21			1:25


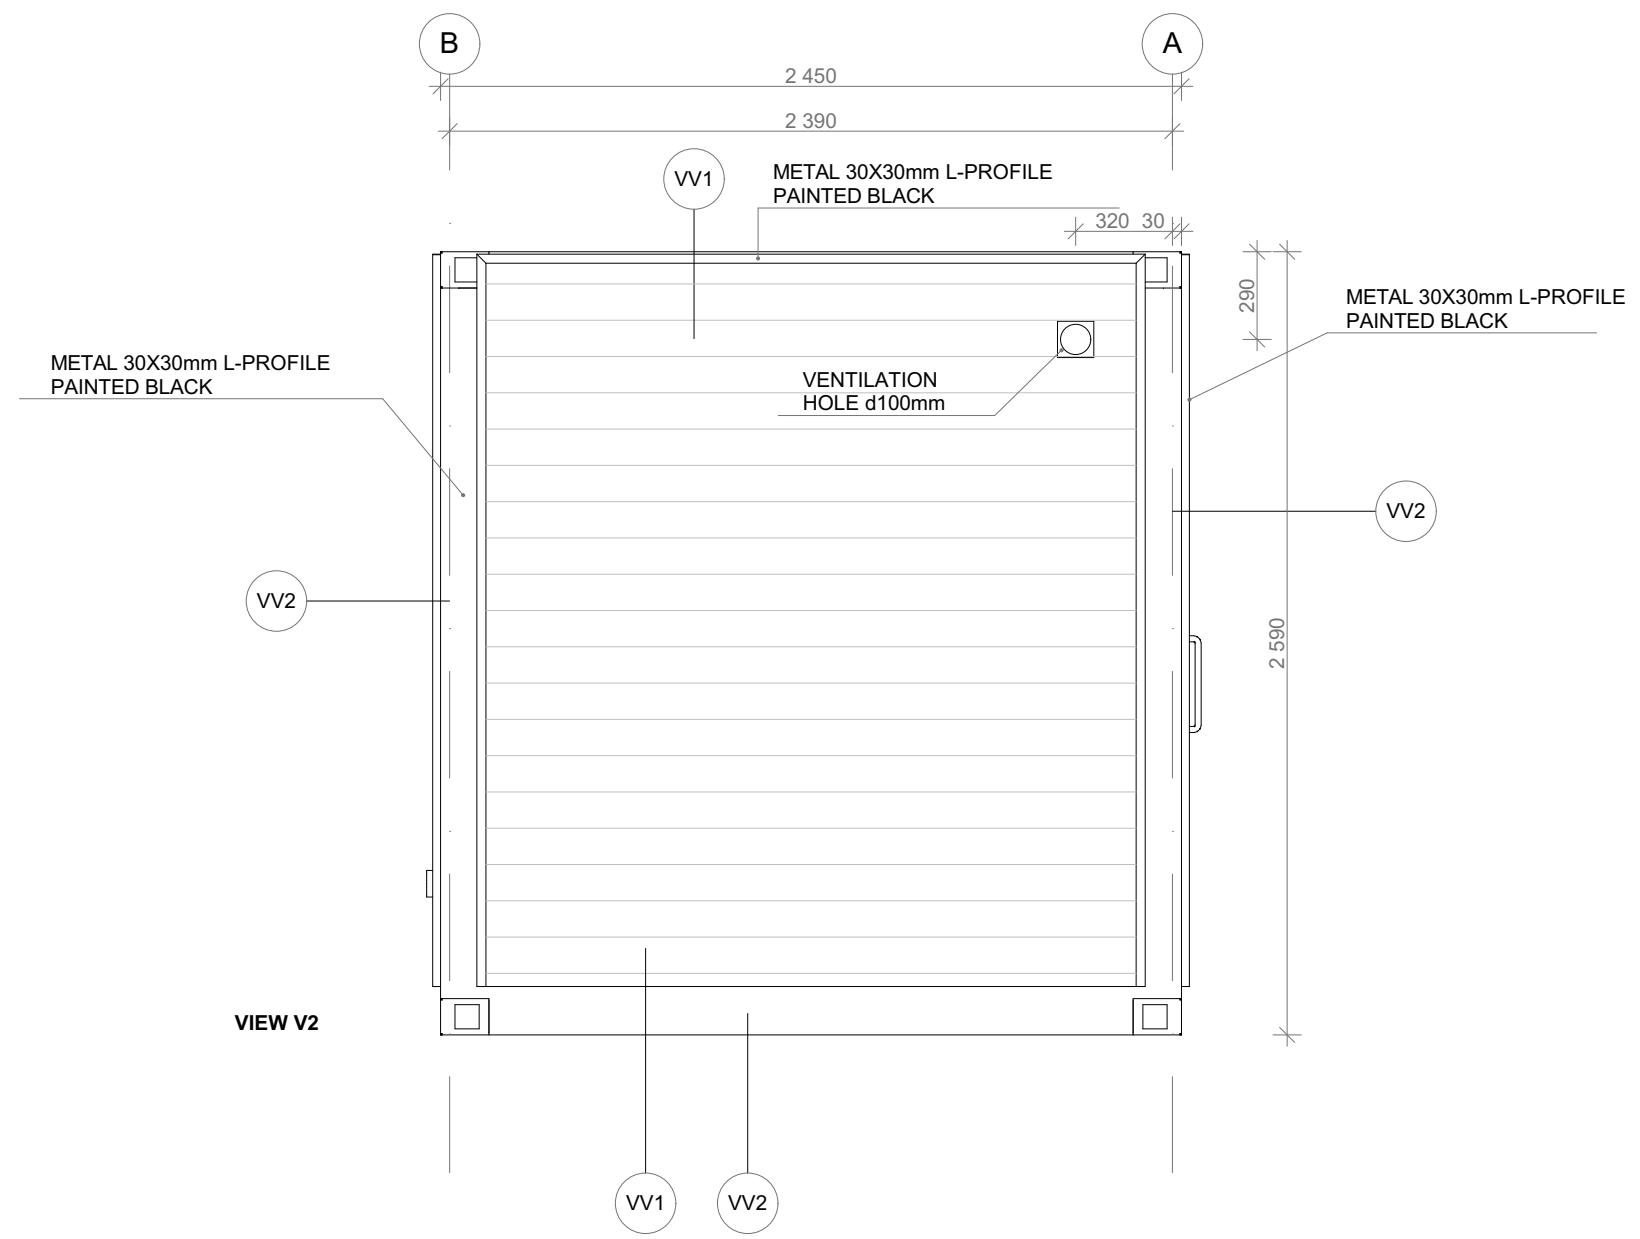


SYMBOLS
EXTERIOR FINISHING

- VV1 — HORIZONTAL WALL BOARD 120...145X18mm, LARCH, PINE, SPRUCE WOOD
SEE FINISHING MATERIALS SPECIFICATION
- VV2 — METAL FRAME PAINTED BLACK

WINDOWS AND DOORS SEE OPEN FILLING SPECIFICATION

SUBSCRIBER		ARRO PROJEKT OÜ EP-11013477 - 0001					
OBJECT ADDRESS		CONTAINER TYPE 2 (RIGHT)		ARCHITECT / Vol. VII		PROJECTOR	
				ANNES ARRO			
DRAWING	VIEWS: V2, V3 AND V4	PART	PHASE	WORK NR	TIME	DOC.MARKING	SCALE
		AR	PP		18.10.21		1:25
ARRO PROJEKT OÜ annes@aahk.ee							SHEET AR 2-T2R

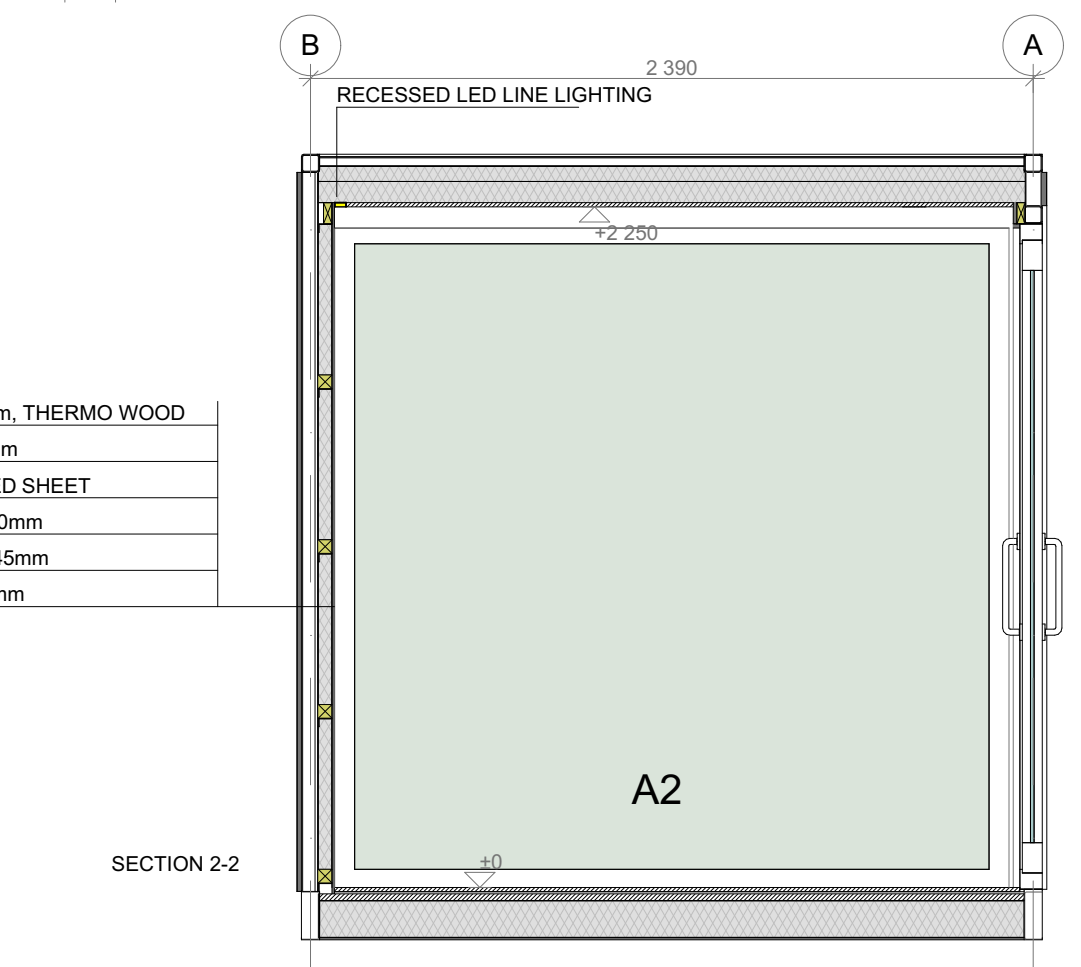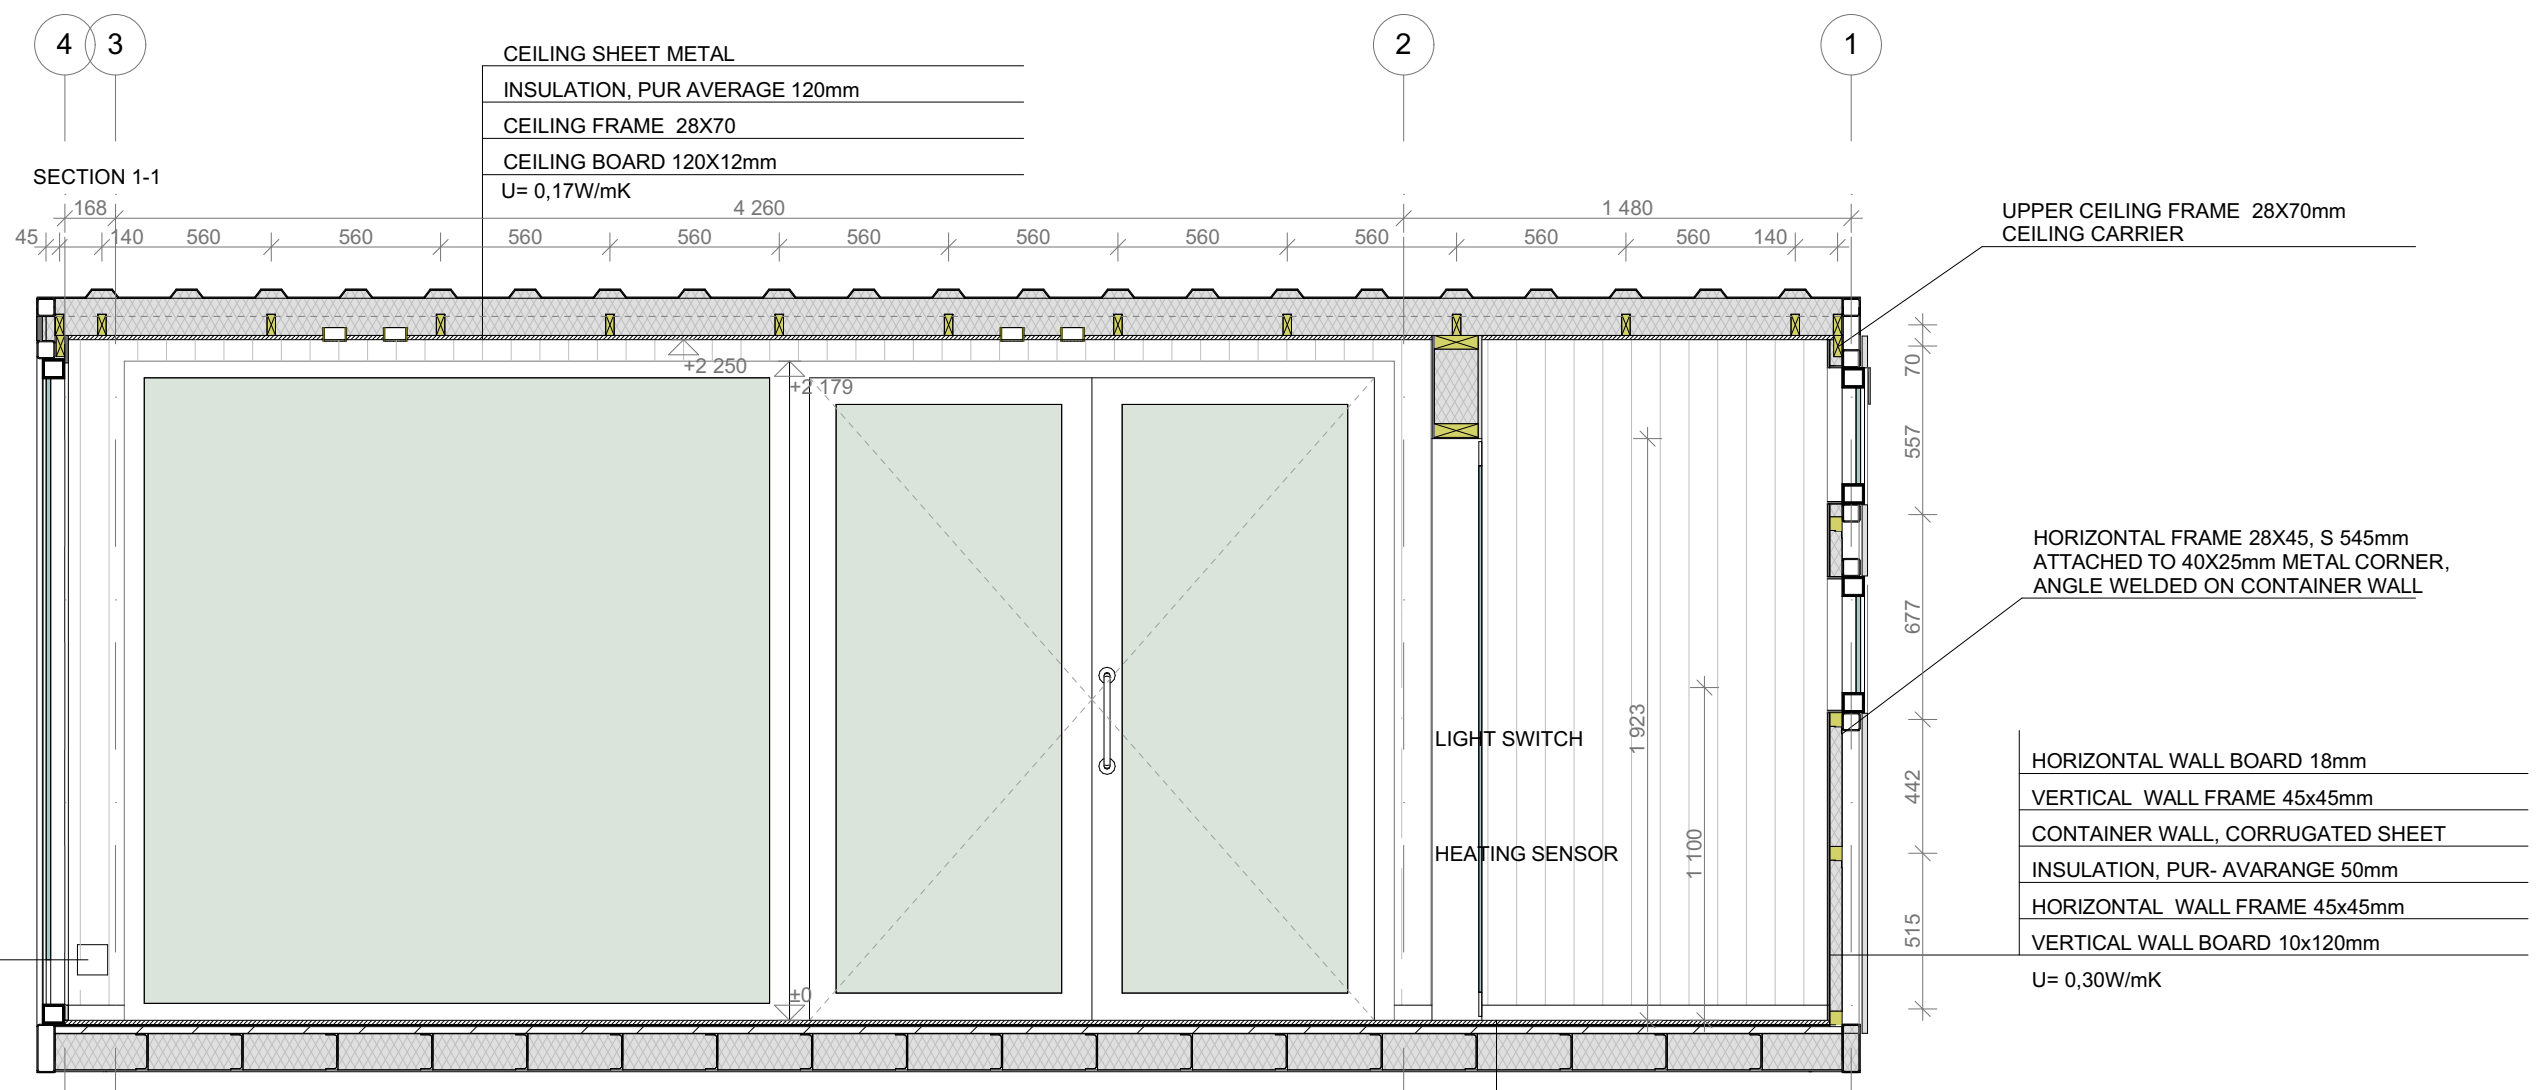


HORIZONTAL WALL BOARD 18mm, THERMO WOOD
 VERTICAL WALL FRAME 45x45mm
 CONTAINER WALL, CORRUGATED SHEET
 INSULATION, PUR- AVARANGE 50mm
 HORIZONTAL WALL FRAME 45x45mm
 VERTICAL WALL BOARD 10x120mm
 U= 0,30W/mK


14mm SINGLE-STRIP PARQUET, NATURAL OAK, OIL WAX
 PARQUET UNDERWEAR 2mm
 UNDERFLOOR HEATING MAT 3mm
 CHIPBOARD OSB 20...22mm
 INSULATION, PUR - AVERAGE 100mm
 WEATHERPROOF PLYWOOD 6mm
 U= 0,19W/mK

SUBSCRIBER		ARRO PROJEKT OÜ EP 11013477 - 0001					
OBJECT ADDRESS	CONTAINER TYPE 2 (RIGHT)		ARCHITECT / Vol. VII		ANNES ARRO		
			PROJECTOR				
DRAWING	SECTIONS L1 AND L2	PART AR	PHASE PP	WORK NR	TIME 18.10.21	DOC.MARKING	SCALE 1:25

SEC 4-4

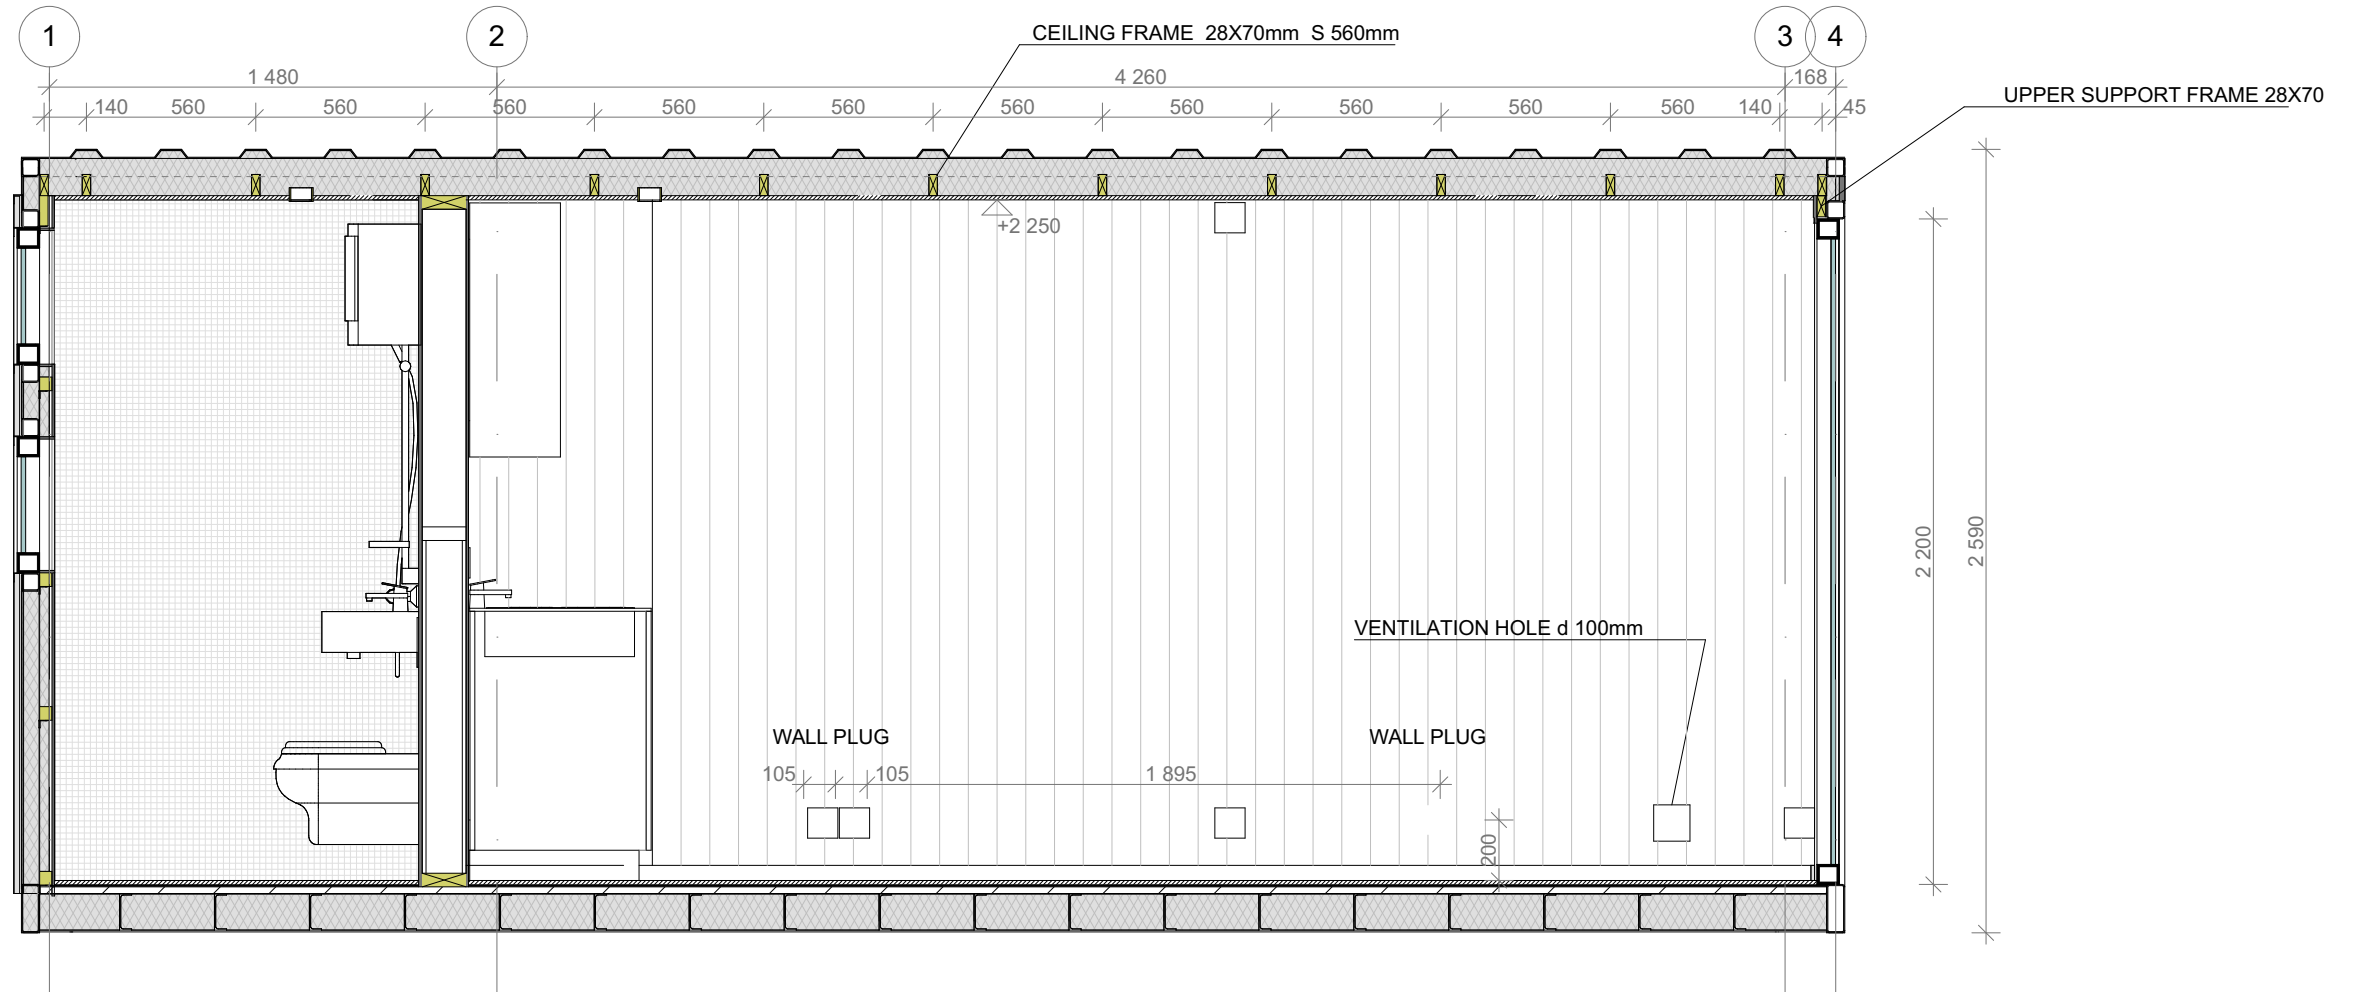

SEC 3-3

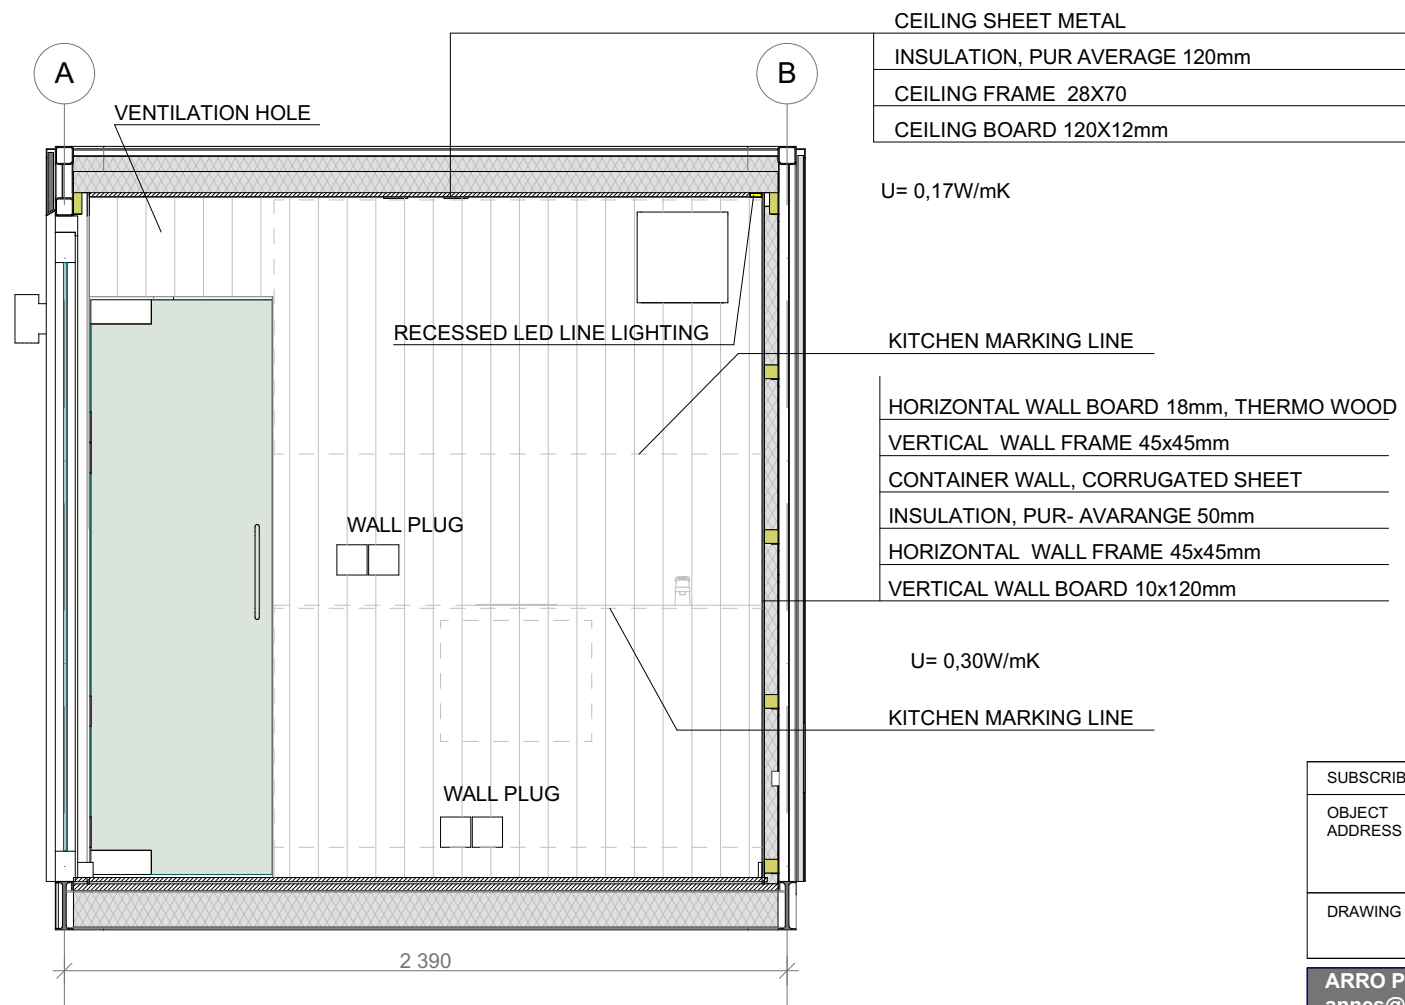

- CEILING SHEET METAL
- INSULATION, PUR AVERAGE 120mm
- CEILING FRAME 28X70
- CEILING BOARD 120X12mm

U= 0,17W/mK

- KITCHEN MARKING LINE
- HORIZONTAL WALL BOARD 18mm, THERMO WOOD
- VERTICAL WALL FRAME 45x45mm
- CONTAINER WALL, CORRUGATED SHEET
- INSULATION, PUR- AVARANGE 50mm
- HORIZONTAL WALL FRAME 45x45mm
- VERTICAL WALL BOARD 10x120mm


U= 0,30W/mK

- KITCHEN MARKING LINE








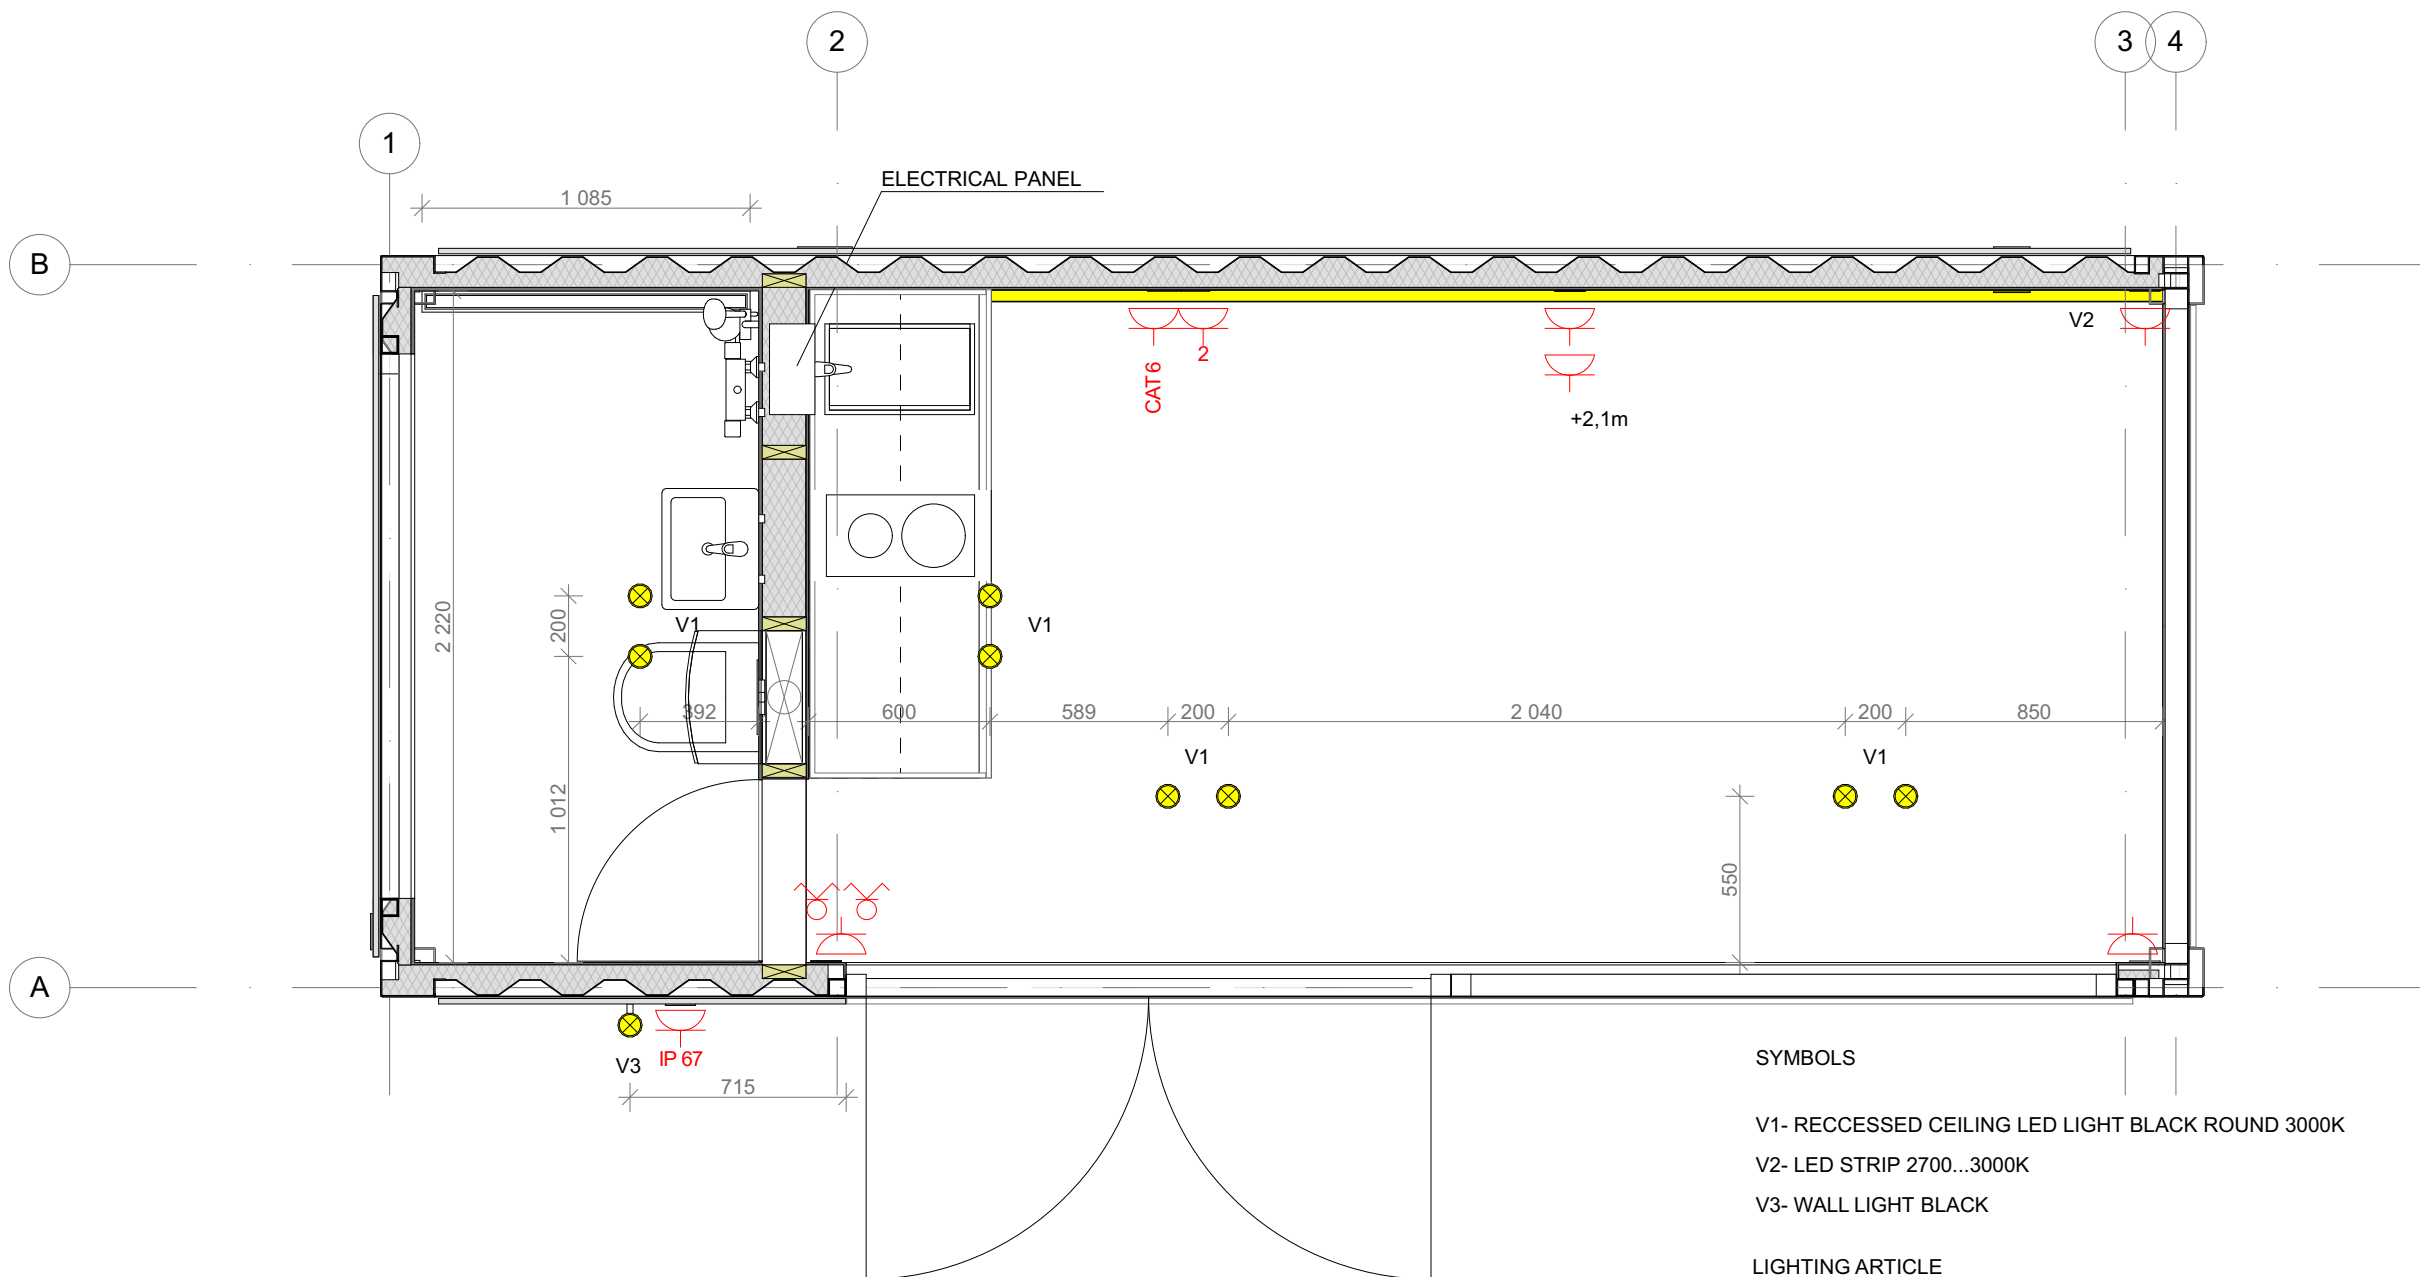

SUBSCRIBER		ARRO PROJEKT OÜ EP 11013477 - 0001					
OBJECT ADDRESS	CONTAINER TYPE 2 (RIGHT)		ARCHITECT / Vol. VII		PROJECTOR		ANNES ARRO
	DRAWING		PART	PHASE	WORK NR	TIME	DOC.MARKING
SECTIONS 3-3 AND 4-4		AR	PP		18.10.21		SCALE 1:25

 ARRO PROJEKT OÜ
annes@aahk.ee

SHEET AR 4-T2R






NOTES
 SWITCH AND WALL PLUGS SELECT FROM THE SERIES JUNG LS, BLACK
 PLUG AND SWITCHES LOCATION SEE SECTION DRAWINGS ID 4 AND ID 5

- SYMBOLS
-  V1- RECESSED CEILING LED LIGHT BLACK ROUND 3000K
 -  V2- LED STRIP 2700...3000K
 -  V3- WALL LIGHT BLACK
 -  LIGHTING ARTICLE
SEE LIGHTING SPECIFICATION
 -  SWITCH
 -  GROUP SWITCH
 -  WALL PLUG
 -  WALL PLUG 2 FRAME
 -  INFO PLUG

SUBSCRIBER		ARRO PROJEKT OÜ EP 11013477 - 0001					
OBJECT ADDRESS	CONTAINER TYPE 2 (RIGHT)		ARCHITECT / Vol. VII		PROJECTOR		
					ANNES ARRO		
DRAWING	LIGHTING PLAN	PART ID	PHASE PP	WORK NR	TIME	DOC.MARKING	SCALE
					18.10.21		1:25

ARRO PROJEKT OÜ
 annes@aahk.ee

SHEET ID 2-T2R

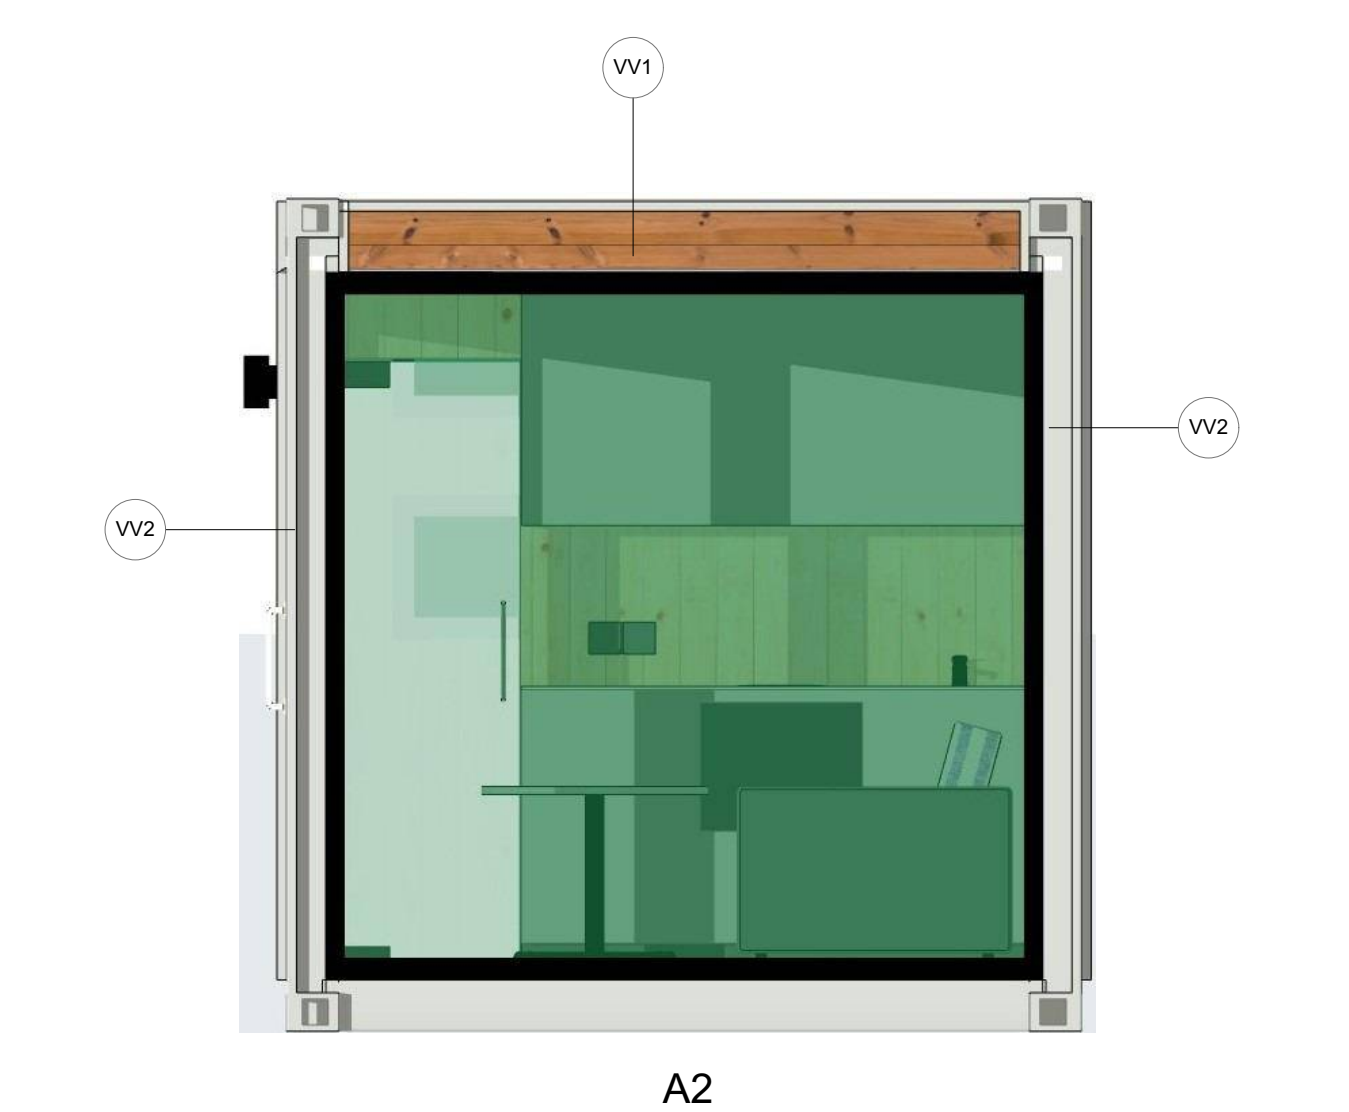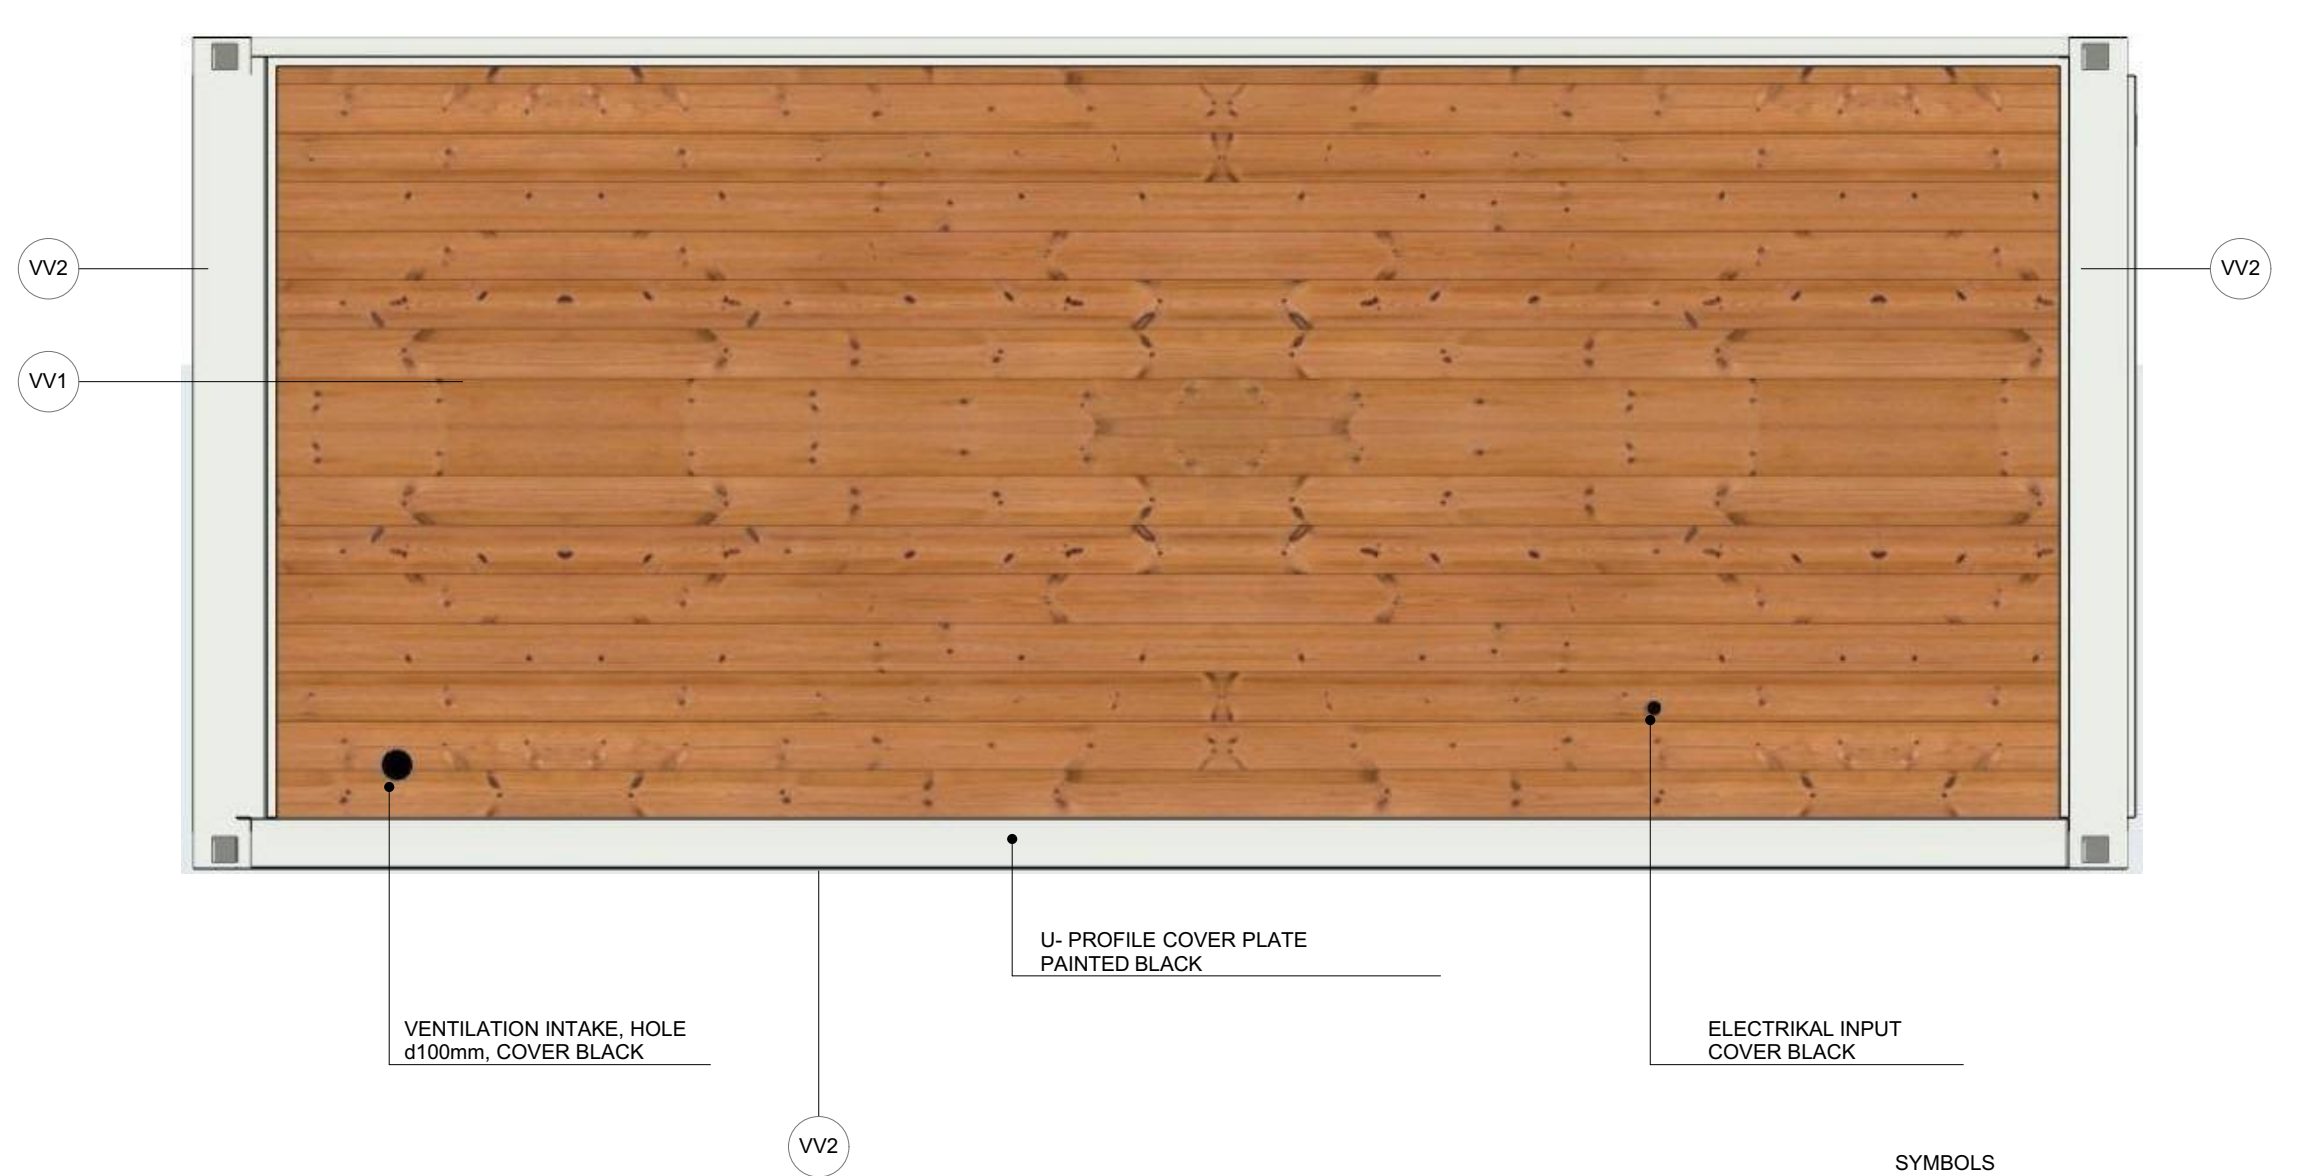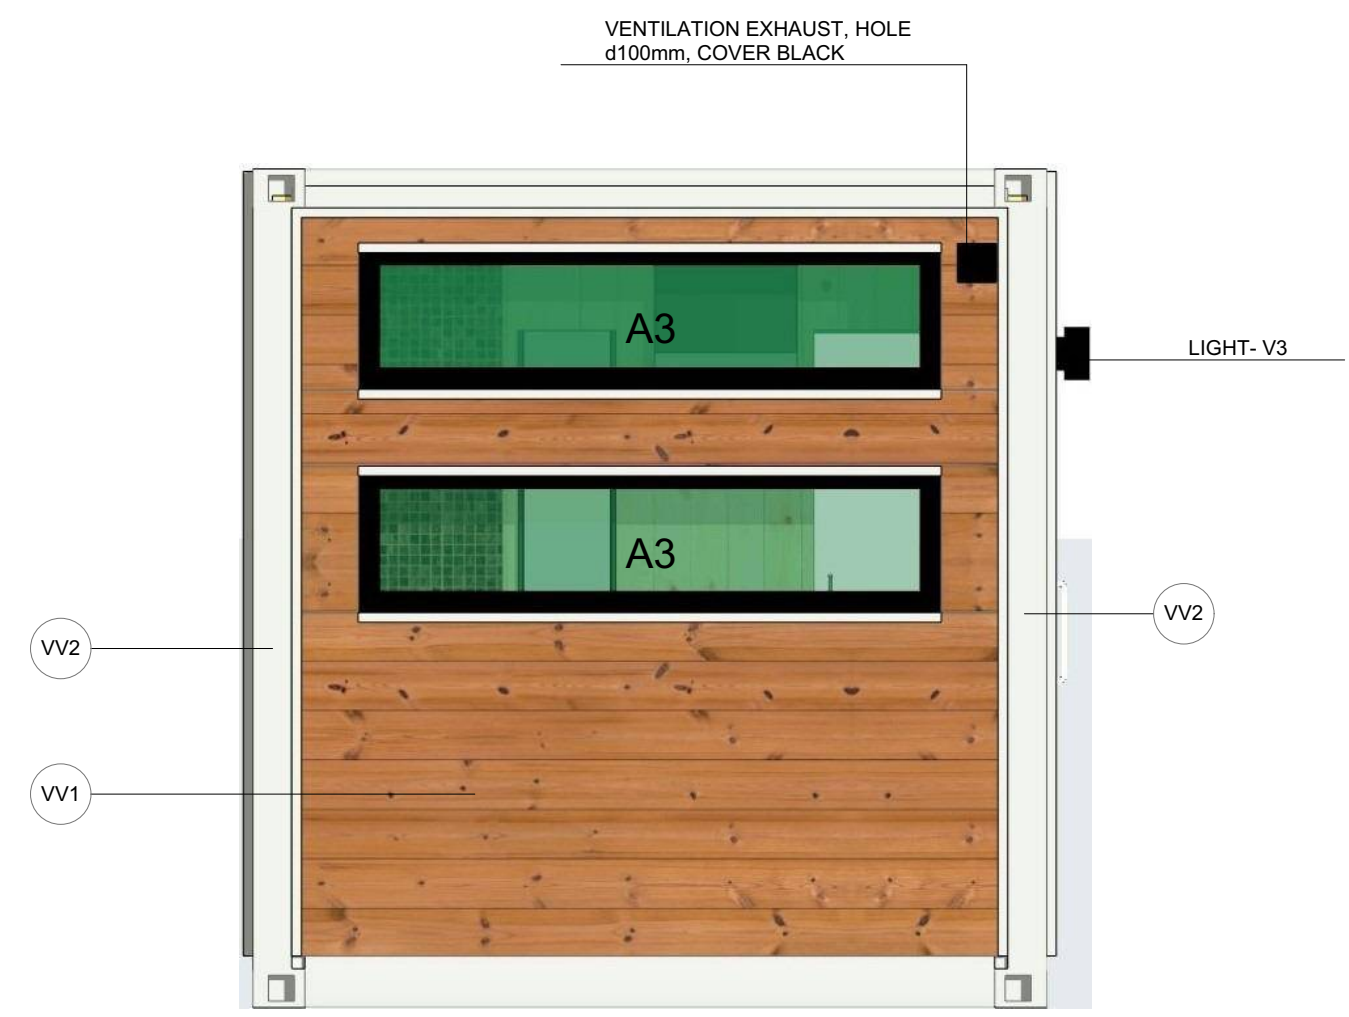

SYMBOLS
EXTERIOR FINISHING

VV1 — HORIZONTAL WALL BOARD 120...145X18mm, LARCH, PINE, SPRUCE WOOD
SEE FINISHING MATERIALS SPECIFICATION

VV2 — METAL FRAME PAINTED BLACK

WINDOWS AND DOORS SEE OPEN FILLING SPECIFICATION

NOTES
TO SPECIFY SEE DRAWINGS AR 1- AR 4

SUBSCRIBER		ARRO PROJEKT OÜ EP-11013477 - 0001					
OBJECT ADDRESS		CONTAINER TYPE 2 (RIGHT)		ARCHITECT / Vol. VII			
		PROJECTOR		ANNES ARRO			
DRAWING	ILLUSTRATIVE VIEWS FACADES	PART AR	PHASE PP	WORK NR	TIME	DOC.MARKING	SCALE
					18.10.21		
ARRO PROJEKT OÜ annes@aahk.ee		SHEET AR 6-T2R					